



Advantek

412 E Garwood Dr
Mount Prospect, IL 60056
(847)387-8107

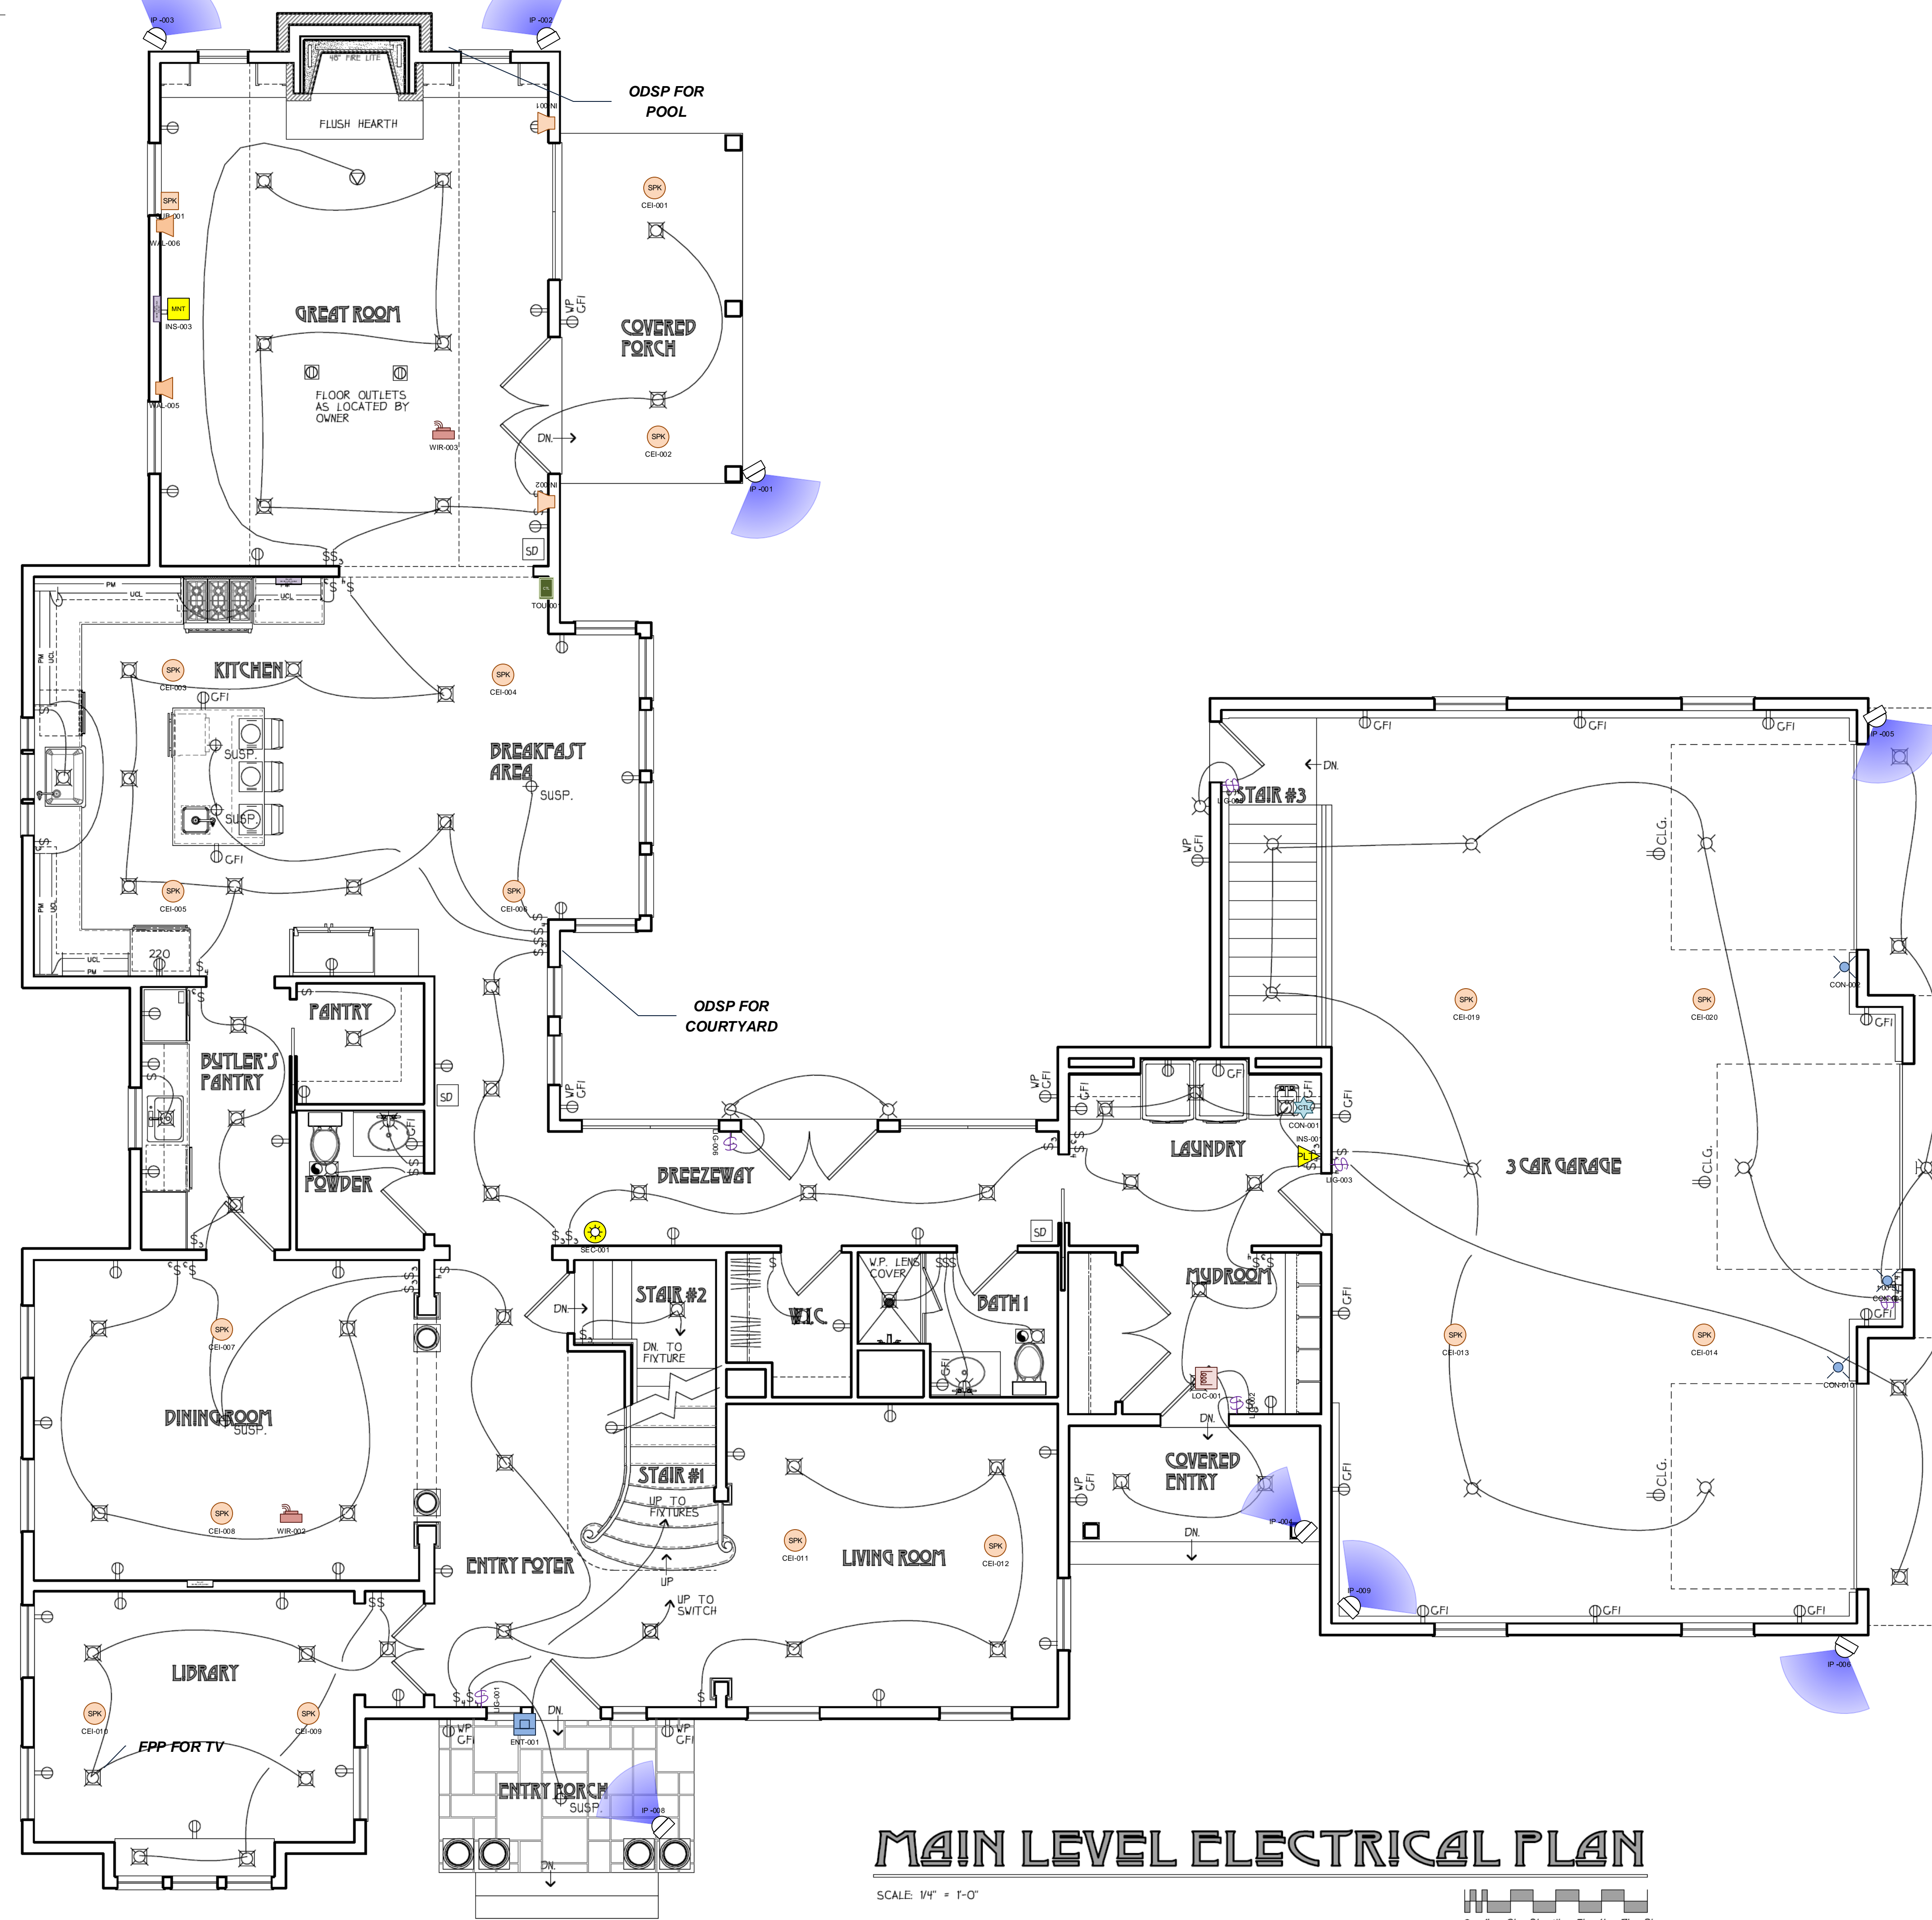

MAIN LEVEL ELECTRICAL PLAN

 SCALE: 1/4" = 1'-0"



NOTES:

- 1) MODIFY ELECTRICAL AS REQUIRED FOR ACTUAL APPLIANCE SELECTIONS.
- 2) SEE FOUNDATION PLAN FOR BASEMENT ELECTRICAL.
- 3) ALL EXHAUST FANS SHALL BE VENTED TO EXTERIOR.

Scale: 1/4" = 1'-0"


Created 8/20/2018
Modified 4/10/2019
Printed 4/10/2019

New Build

First Floor Plan


Advantek

412 E Garwood Dr
Mount Prospect, IL 60056
(847)387-8107

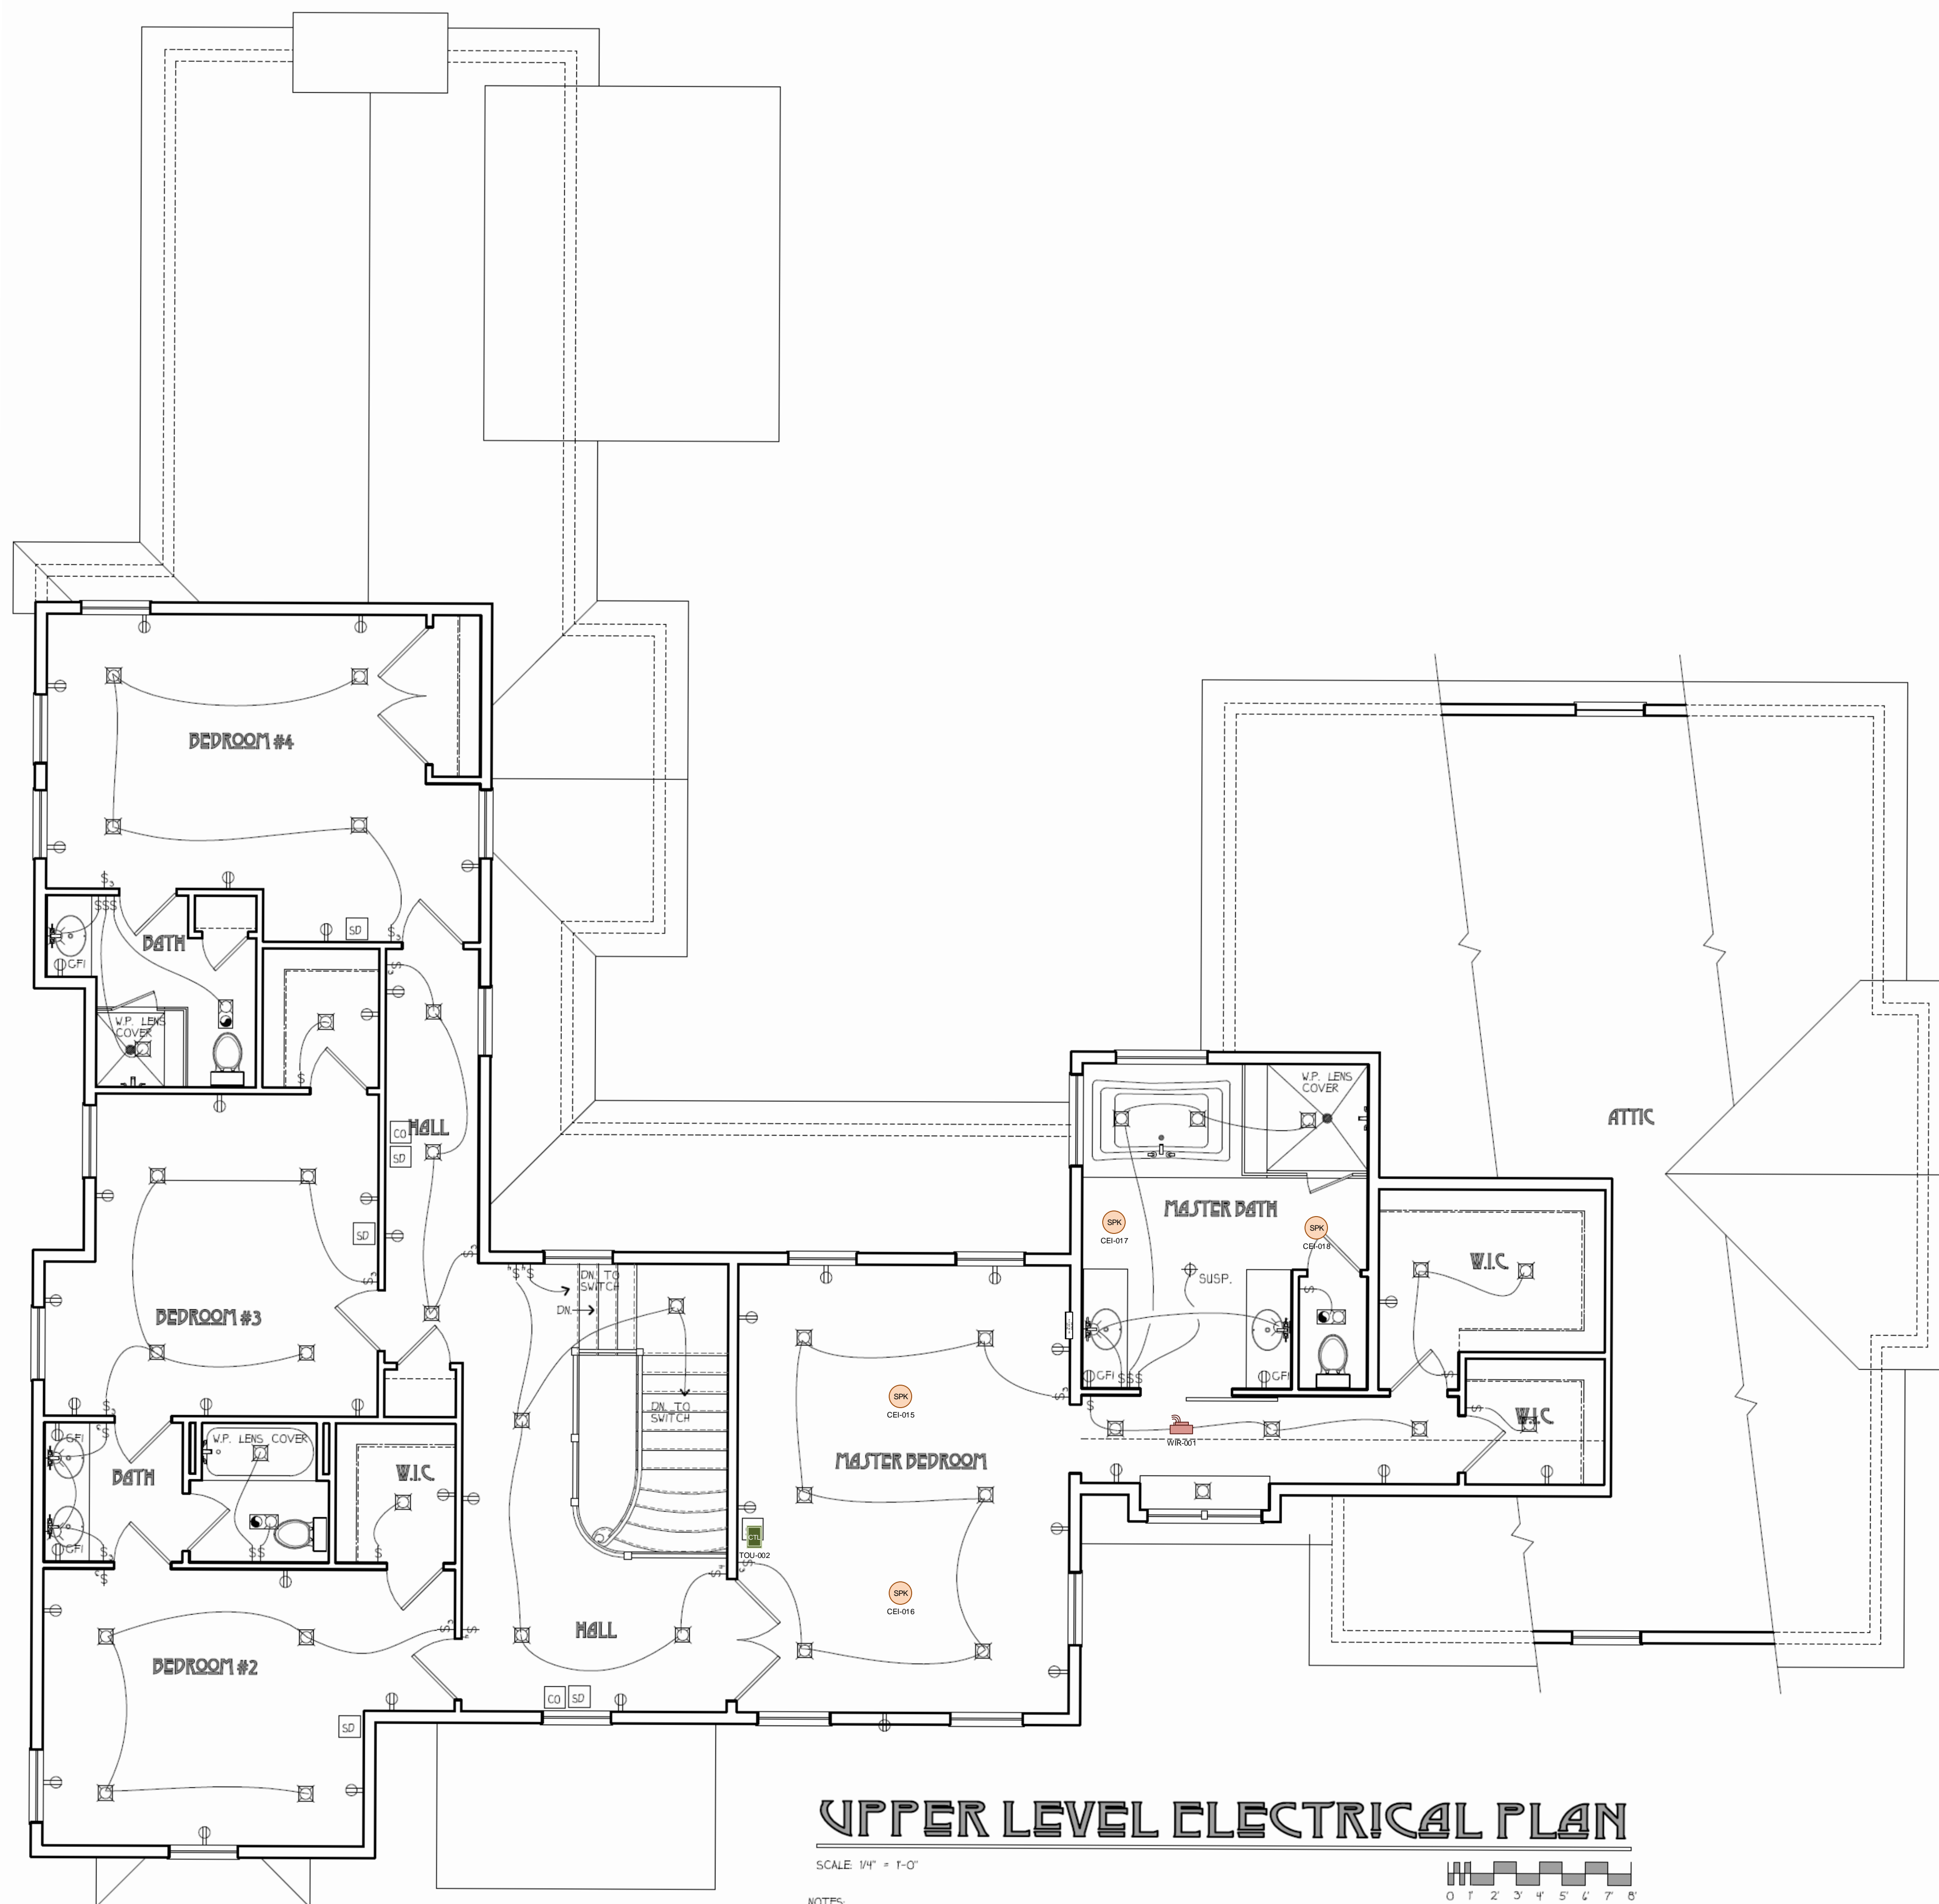

UPPER LEVEL ELECTRICAL PLAN

 SCALE 1/4" = 1'-0"



NOTES:

- 1) LIGHT FIXTURES LOCATED ABOVE SHOWERS OR BATHTUBS SHALL BE SEALED UNITS LABELED AS SUITABLE FOR A WET ENVIRONMENT AS REQUIRED BY CODE.
- 2) ALL EXHAUST FANS SHALL BE VENTED TO EXTERIOR.
- 3) PROVIDE PULL CHAIN LTC. IN ATTIC SPACES.
- 4) PROVIDE ELECTRIC IN ATTIC FOR RADON VENTING SYSTEM AS REQUIRED.

Scale: 1/4" = 1'-0"

Created 8/20/2018
Modified 4/10/2019
Printed 4/10/2019

New Build

Second Floor Plan